


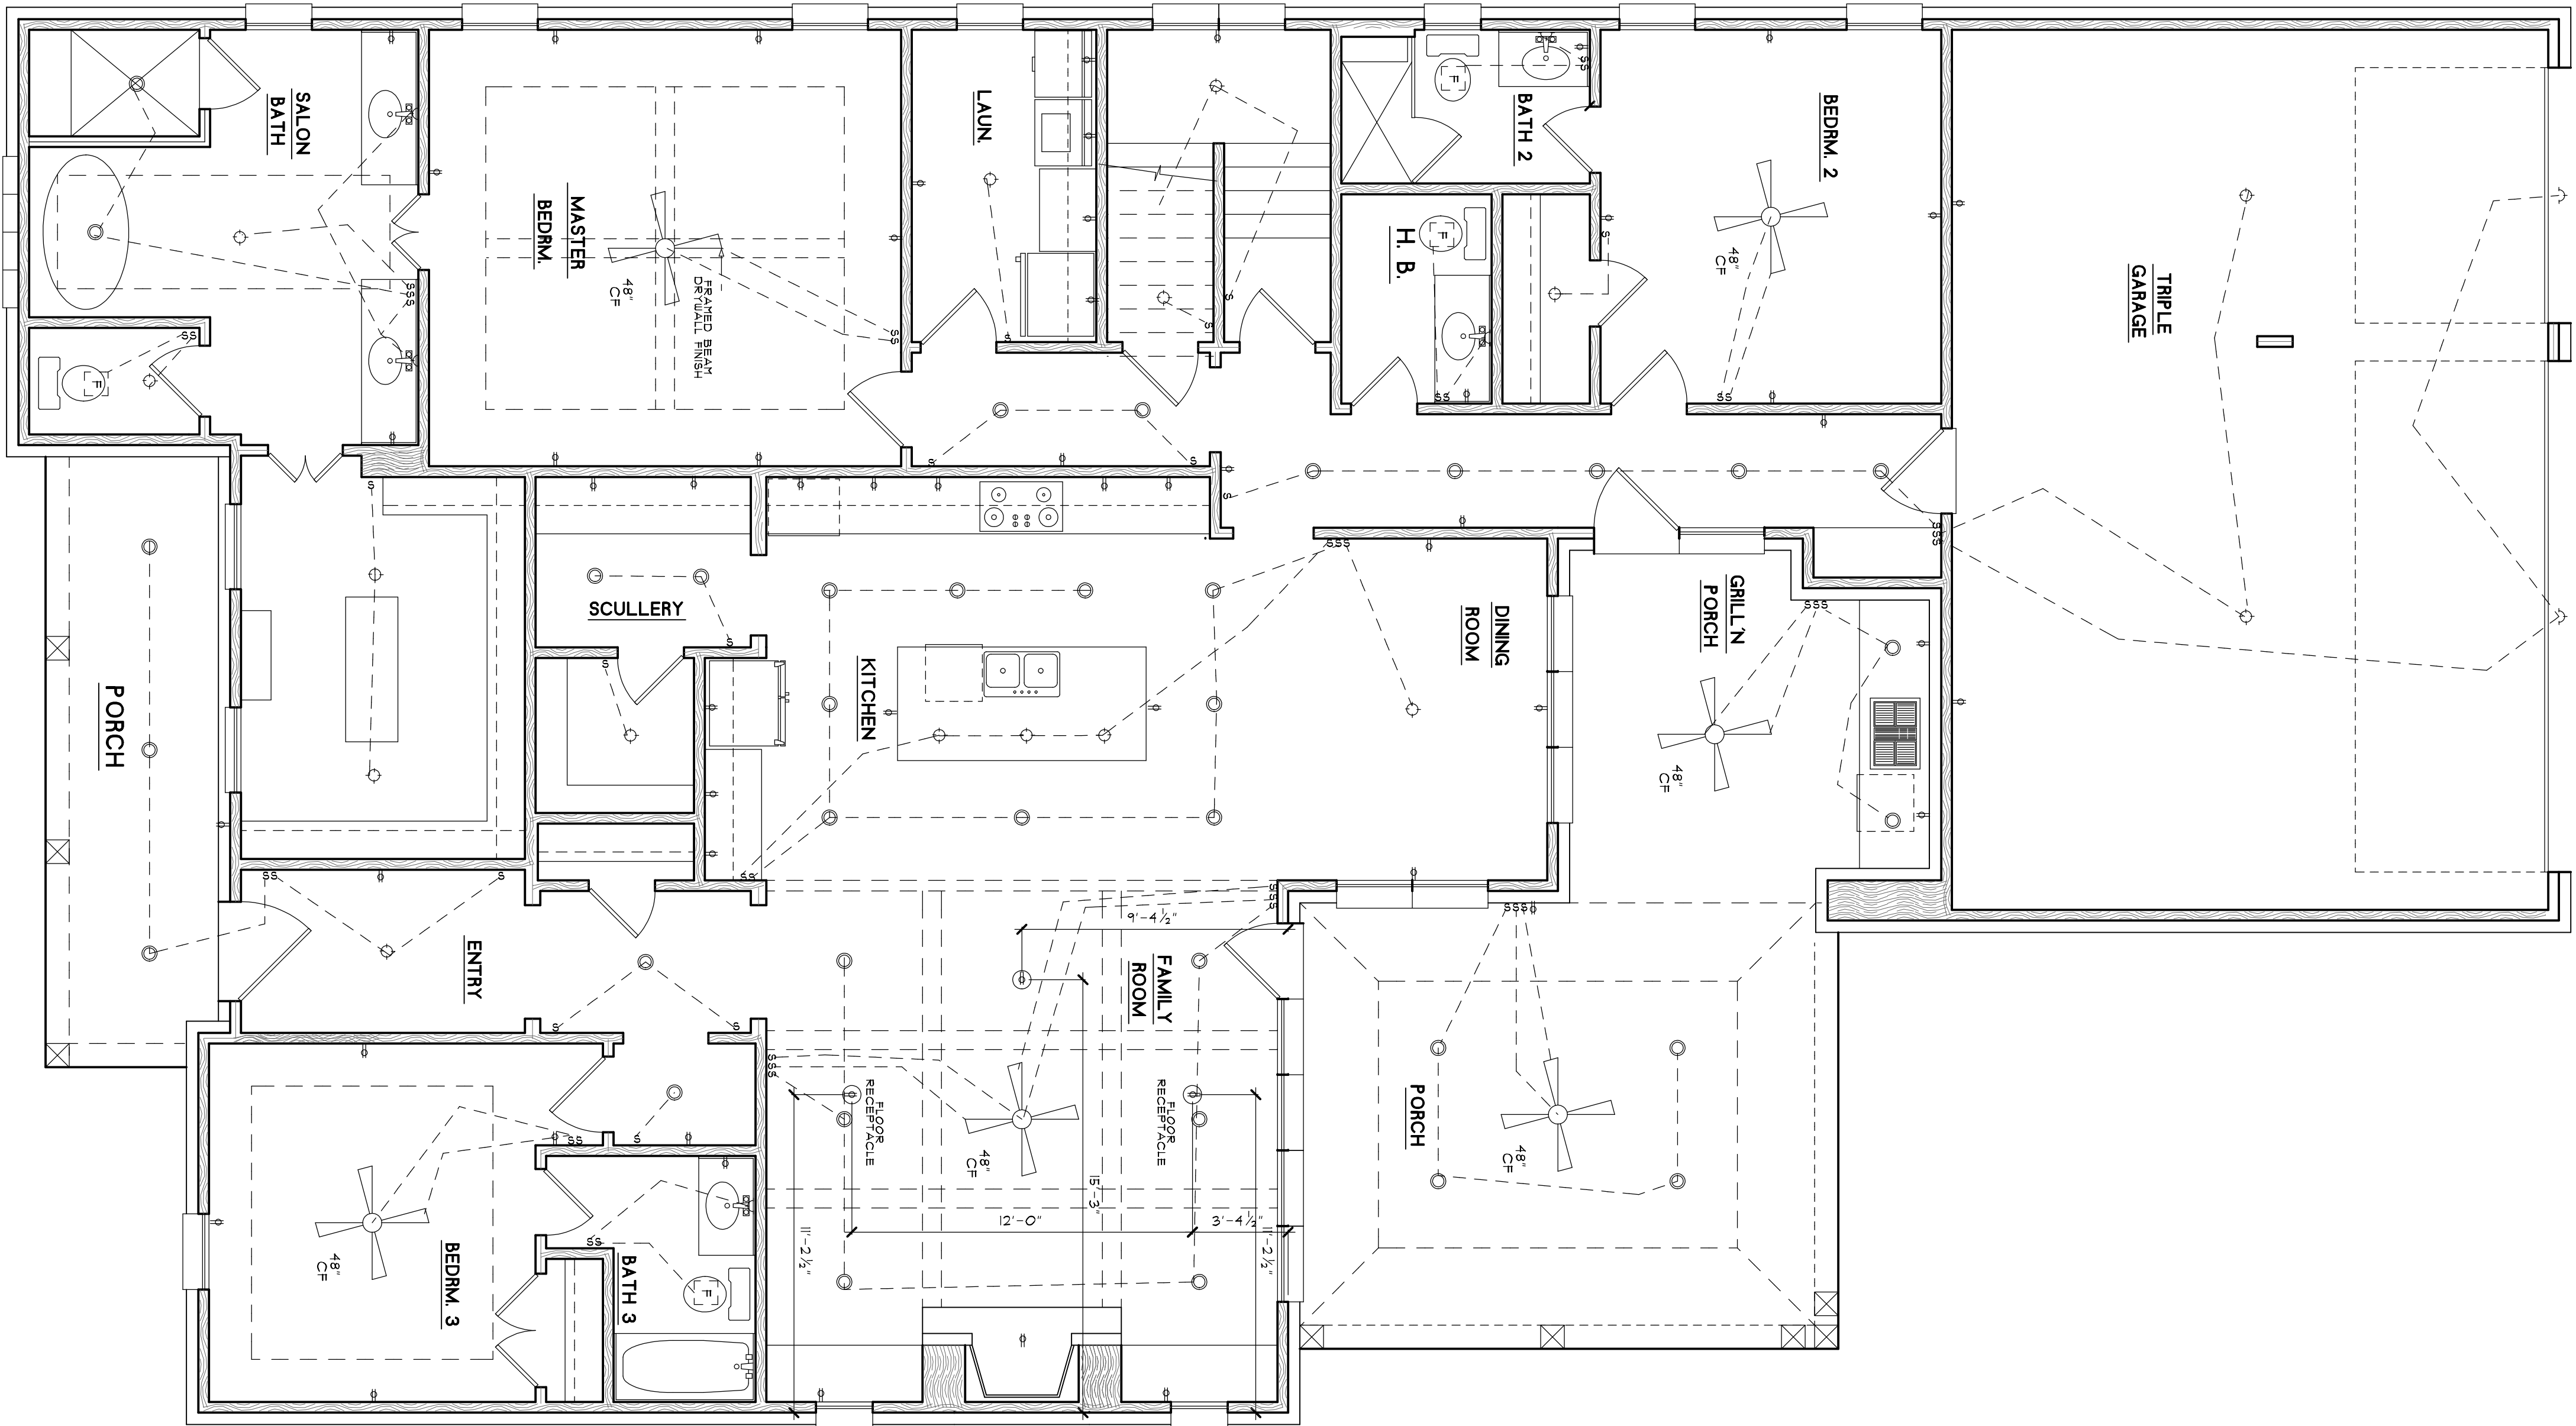

FIRST FLOOR ELECTRICAL PLAN

1/4"=1'-0"

AREAS:
HTD DN 2408 SQ. FT.
FUT UP 879 SQ. FT.
TOTAL HTD. 2408 SQ. FT.
PORCHES 6 1/2 SQ. FT.
GAR & STOR. 779 SQ. FT.


AMERICAN INSTITUTE
OF BUILDING DESIGN

B A
D

CLASSIC HOME DESIGNS

ED YENDREK AND ASSOCIATES
185 N MAIN, SUITE 101
COLLIERVILLE, TENNESSEE 38017
PHONE: 901-854-6900 FAX: 901-854-7170
WWW.CHDHOME.COM

© CLASSIC HOME DESIGNS
COPYRIGHT 2024

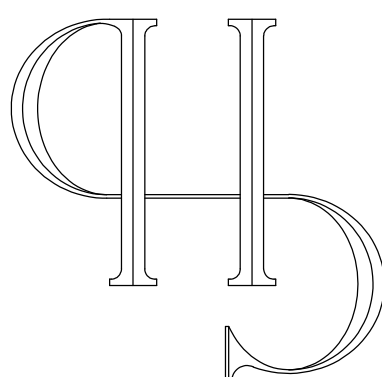

DRAWN :
CHECKED :

DATE : 2-4-2024

SCALE : AS NOTED

JOB NO. : B700-PP195

SHEET